


# PC EXHIBIT G

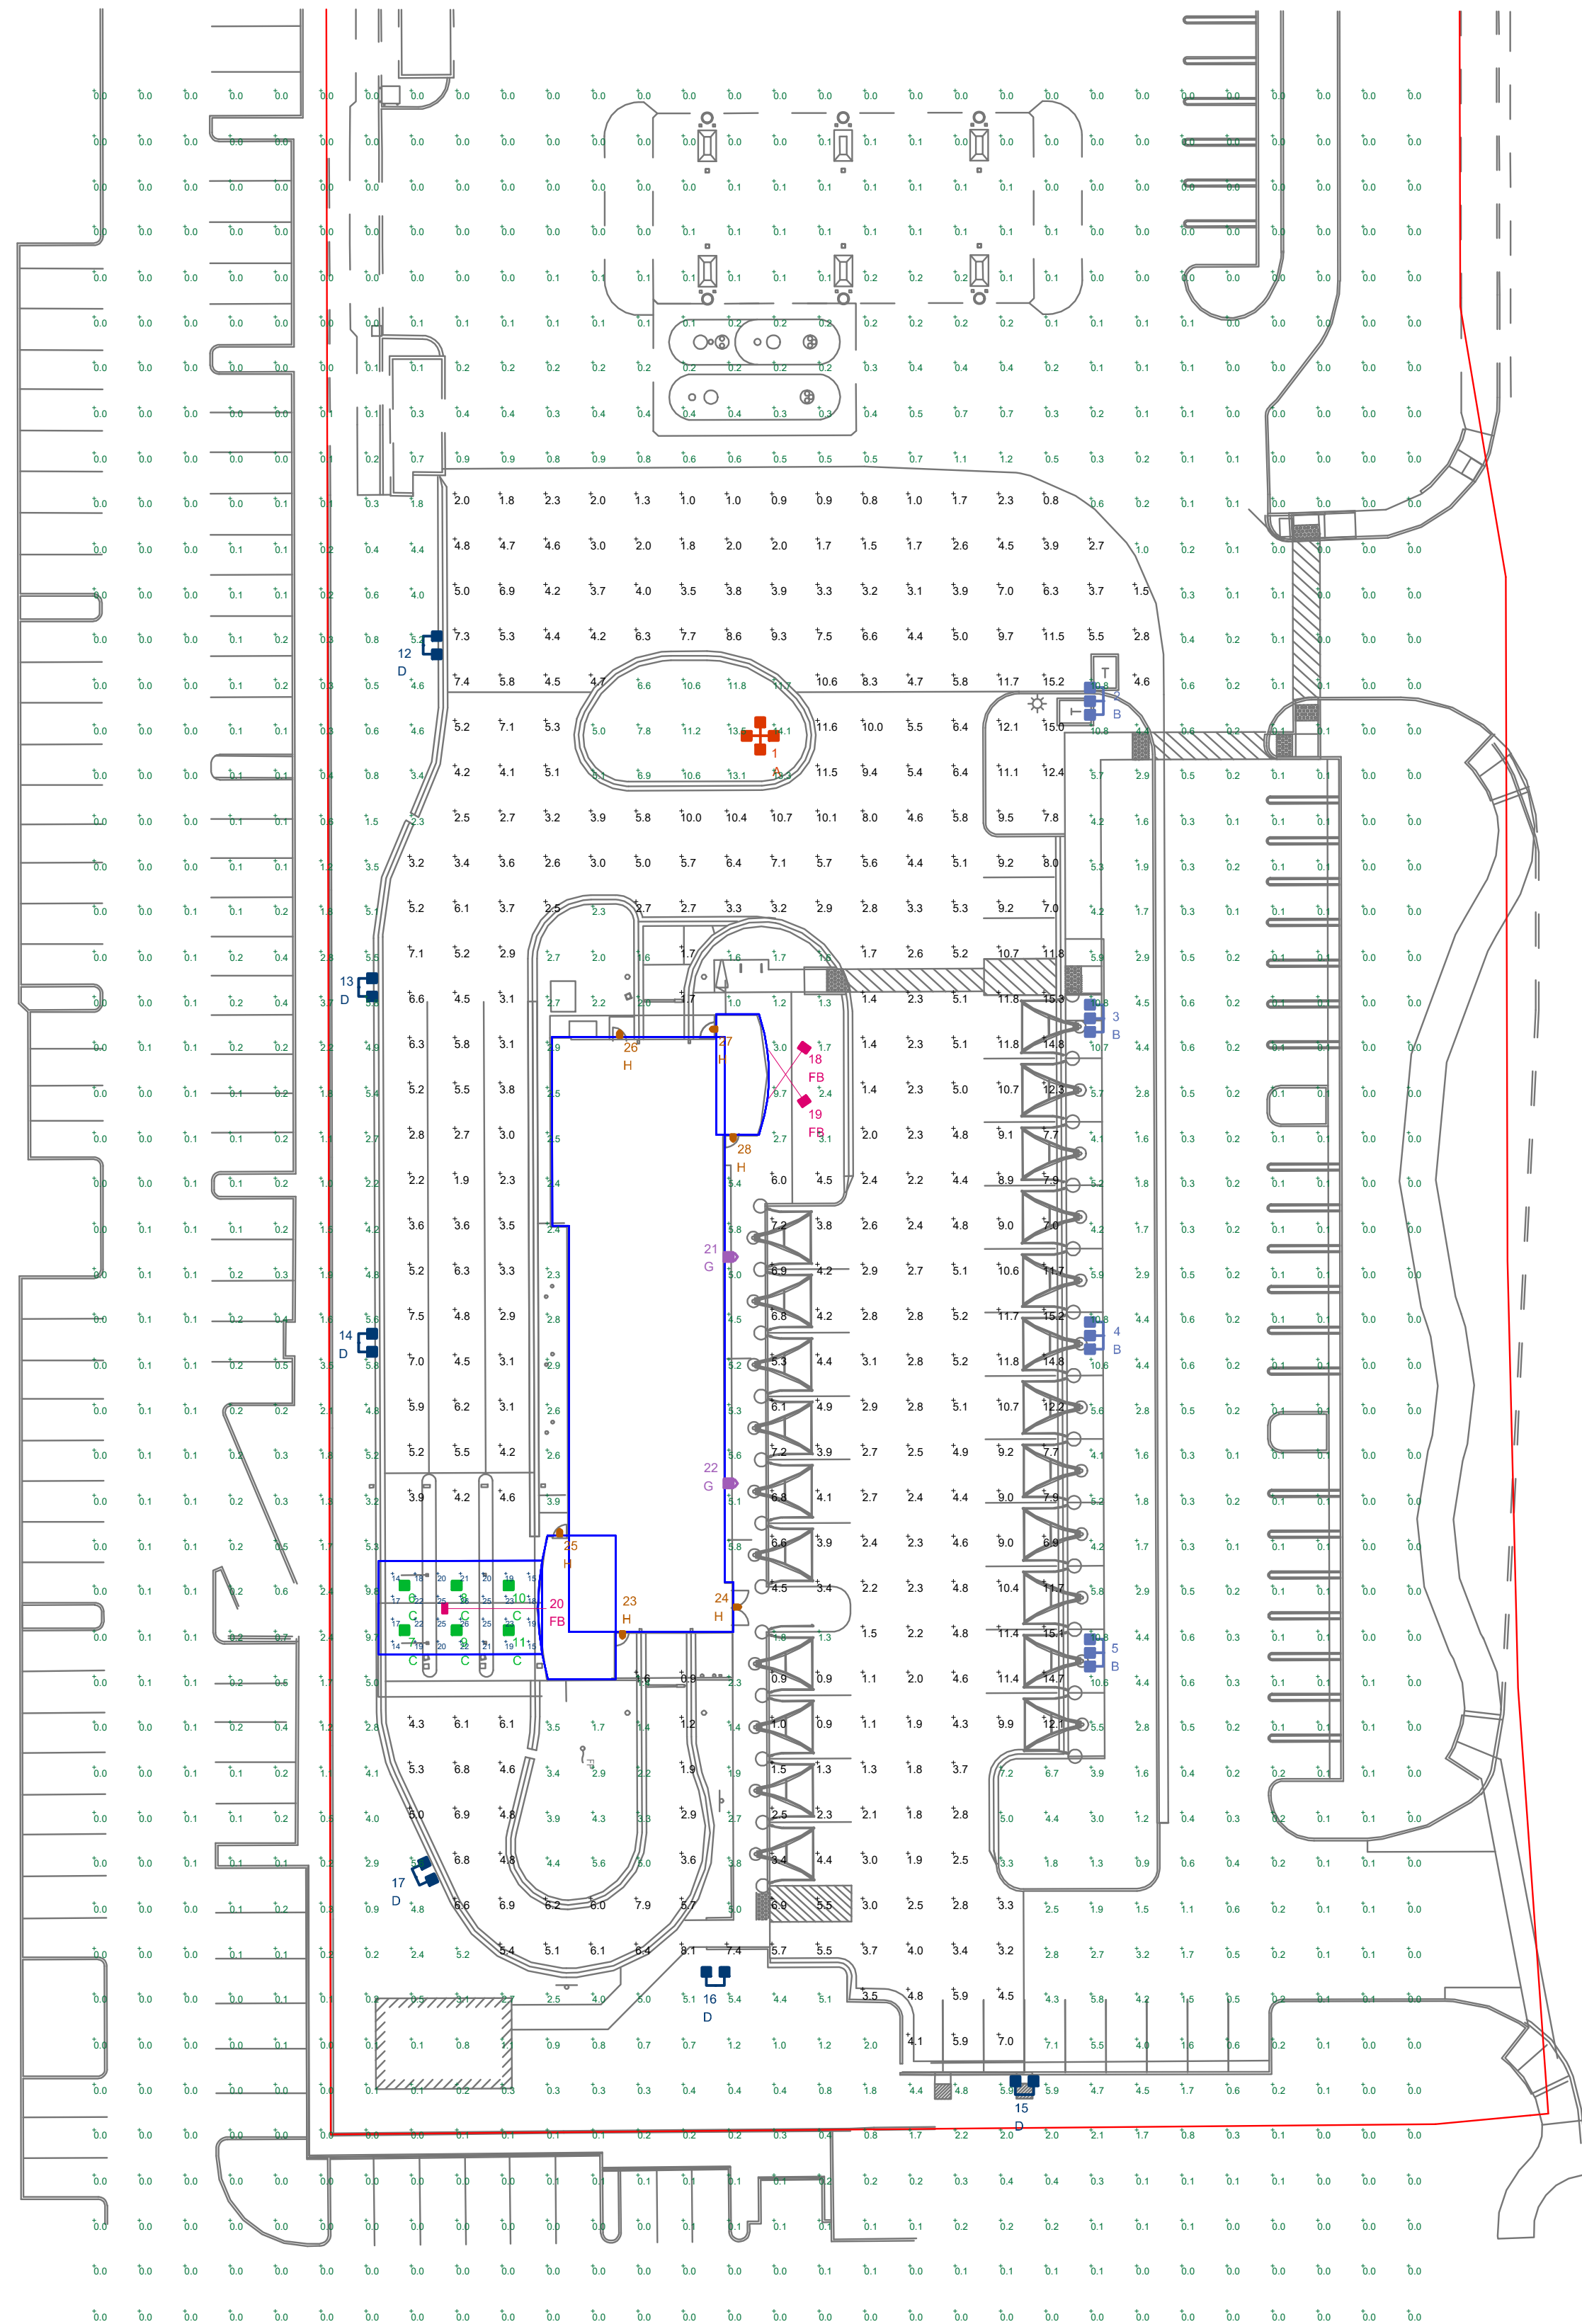

FOOTHILLS BLVD

NOTES:  
 - ALL AREA LIGHTS ON NEW 17 FT. POLES MOUNTED ON 3 FT. CONCRETE BASES  
 - NO IES FILE AVAILABLE FOR FIXTURE FB WITH FULL VISOR. PHOTOMETRY SHOWN IS LESS VISOR. FIXTURE IS TO BE ORDERED WITH VISOR

FOOTCANDLE LEVELS CALCULATED AT GRADE USING INITIAL LUMEN VALUES					
LABEL	AVG	MAX	MIN	AVG/MIN	MAX/MIN
CANOPY	20.36	26	14	1.45	1.86
PAVED	5.18	15.3	0.8	6.48	19.13
UNDEFINED	0.97	14.1	0.0	N.A.	N.A.

LUMINAIRE LOCATION SUMMARY		
LUM NO.	LABEL	MTG. HT.
1	A	20
2	B	20
3	B	20
4	B	20
5	B	20
6	C	15
7	C	15
8	C	15
9	C	15
10	C	15
11	C	15
12	D	20
13	D	20
14	D	20
15	D	20
16	D	20
17	D	20
18	FB	2
19	FB	2
20	FB	18
21	G	15
22	G	15
23	H	9
24	H	9
25	H	9
26	H	9
27	H	9
28	H	9

LUMINAIRE SCHEDULE											
SYMBOL	QTY	LABEL	ARRANGEMENT	LUMENS	LLF	BUG RATING	WATTS/LUMINAIRE	TOTAL WATTS	MANUFACTURER	CATALOG LOGIC	
	1	A	4 @ 90 DEGREES	11648	1.020	B2-U0-G2	86	344	Cree Inc	OSQ-A-NM-4ME-B-57K-UL-XX	
	4	B	TRIPLE	9196	1.020	B1-U0-G2	86	1032	Cree Inc	OSQ-A-NM-3ME-B-57K-UL-XX + OSQ-BLSMF	
	6	C	SINGLE	4520	1.020	B2-U0-G1	31	186	Cree Inc	CPY250-B-DM-F-C-UL-XX-57K	
	6	D	TWIN	8950	1.020	B1-U0-G2	86	1032	Cree Inc	OSQ-A-NM-4ME-B-57K-UL-XX + OSQ-BLSMF	
	3	FB	SINGLE	3731	1.000	N.A.	29.3	87.89999	Maxlite	MSF29UW-50BX + MSF29-FULLVISOR (SEE NOTES)	
	2	G	SINGLE	11259	1.020	B3-U0-G3	134	268	CREE, INC.	SEC-EDG-4M-WM-06-E-UL-XX-700-57K	
	6	H	SINGLE	1530	1.000	N.A.	15.8	94.8	BARRON LIGHTING GROUP	SLW-15-4K-XX-EM (BY OTHERS)	

DISCLAIMER

ANY SITE PLAN(S), FLOOR PLAN(S), RENDERING(S), LIGHTING LAYOUT(S) AND PHOTOMETRIC PLAN(S) INCLUDING BUT NOT LIMITED TO ANY PROJECT(S) CREATED/PRODUCED BY RED LEONARD ASSOCIATES INC., ARE ONLY INTENDED FOR ILLUSTRATION AND QUOTING PURPOSES ONLY. RED LEONARD ASSOCIATES HAS THE RIGHT TO USE THIRD PARTY LASERS, SCANNERS, AND CAMERAS BUT ACTUAL PROJECT CONDITIONS, DIMENSIONS, AND ACCURACY OF MEASUREMENTS MAY DIFFER FROM THESE OR ANY PARAMETERS. RED LEONARD ASSOCIATES INC. ASSUMES NO LIABILITY FOR WHAT IS CREATED/PRODUCED IN THESE RECREATIONS. THIS INCLUDES BUT IS NOT LIMITED TO THE USE OF, INSTALLATION OF AND/OR INTEGRITY OF EXISTING BUILDING(S), SURROUNDING AREA FOR PROJECT(S) SUCH AS EXISTING POLES(S), ANCHOR BOLTS(S), BASE(S), ARCHITECTURAL AND SIGNAGE STRUCTURE(S), LANDSCAPING PLAN(S), LIGHTING PLAN(S), FIXTURE SELECTION(S) AND PLACEMENT, MATERIAL(S), COLOR ACCURACY, TEXTURE(S), AND ANYTHING ATTRIBUTED TO PHOTO REALISM THAT IS CREATED. FURTHERMORE, RED LEONARD ASSOCIATES INC., DOES NOT ASSUME LIABILITY WHATSOEVER FOR ANY PURCHASES MADE BY CLIENT BEFORE, DURING, OR AT THE CONCLUSION OF THE PUBLISHED WORK. THE CUSTOMER, ITS RELATIVE AFFILIATES, AS WELL AS ANY OTHER PERSON(S) IN VIEWING OF THIS PRODUCT IS RESPONSIBLE FOR VERIFYING COMPLIANCE WITH ANY BUT NOT LIMITED TO ALL CODES, PERMITS, RESTRICTIONS, INSTRUCTIONS, PURCHASES, AND INSTALLATIONS OF OBJECTS VIEWED WITHIN THIS DOCUMENT(S) OR PROJECT(S). SYMBOLS ARE NOT DRAWN TO SCALE. SIZE IS FOR CLARITY PURPOSES ONLY. SIZES AND DIMENSIONS ARE APPROXIMATE. ACTUAL MEASUREMENTS MAY VARY. DRAWINGS ARE NOT INTENDED FOR ENGINEERING OR CONSTRUCTION USE. THIS DOCUMENT, ANY RED LEONARD DRAWING(S), OR PROJECT(S) IS NOT TO BE USED AND/OR INTENDED FOR ENGINEERING OR CONSTRUCTION PURPOSES, BUT FOR ILLUSTRATIVE PURPOSES ONLY. ANY LOCATIONS OF EMERGENCY LIGHTING SHOWN WERE PROVIDED BY OTHERS. RED LEONARD ASSOCIATES IS NOT RESPONSIBLE FOR INSUFFICIENT LIGHTING DURING AN EMERGENCY EVENT. ANY USE OF THIS DOCUMENTATION AND/OR OTHER ARTICLES PRODUCED BY RED LEONARD WITHOUT WRITTEN AUTHORIZATION FROM JAYNE J. LEONARD IS STRICTLY PROHIBITED.

SCALE: 1" = 30'  
 DWG SIZE: D  
 LAYOUT BY: LMP  
 DATE: 01/08/2021

PROJECT NAME:  
**TOMMY CARWASH**  
**ROSEVILLE, CA**  
 DRAWING NUMBER:  
**RL-7136-S1-R1**

REV.	BY	DATE	DESCRIPTION
R1	PLD	07/21/2021	REVISED PER UPDATED SITE PLAN