

PC EXHIBIT D



Architects

K12 Architects, Inc
 3090 Fite Circle, #104
 Sacramento, CA 95827
 PH:(916) 455-6500 FAX:(916) 455-8100

CONSULTANTS:

CONTRACTOR:

PROJECT:

**BEE SHINE
 CAR WASH**


NEW CAR WASH

**1100 ORLANDO AVE
 ROSEVILLE, CA 95661**

DEVELOPER:

REVISIONS:
 PLANNING COMMENTS 1/26/23

PROFESSIONAL SEALS:

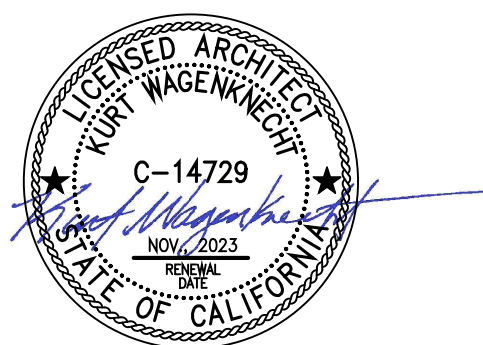


PROJECT NUMBER: **22-005** PROJECT DATE: **4-12-2022**


SHEET CONTENTS:

**OVERALL
 FLOOR PLAN**

SHEET NUMBER:

A200

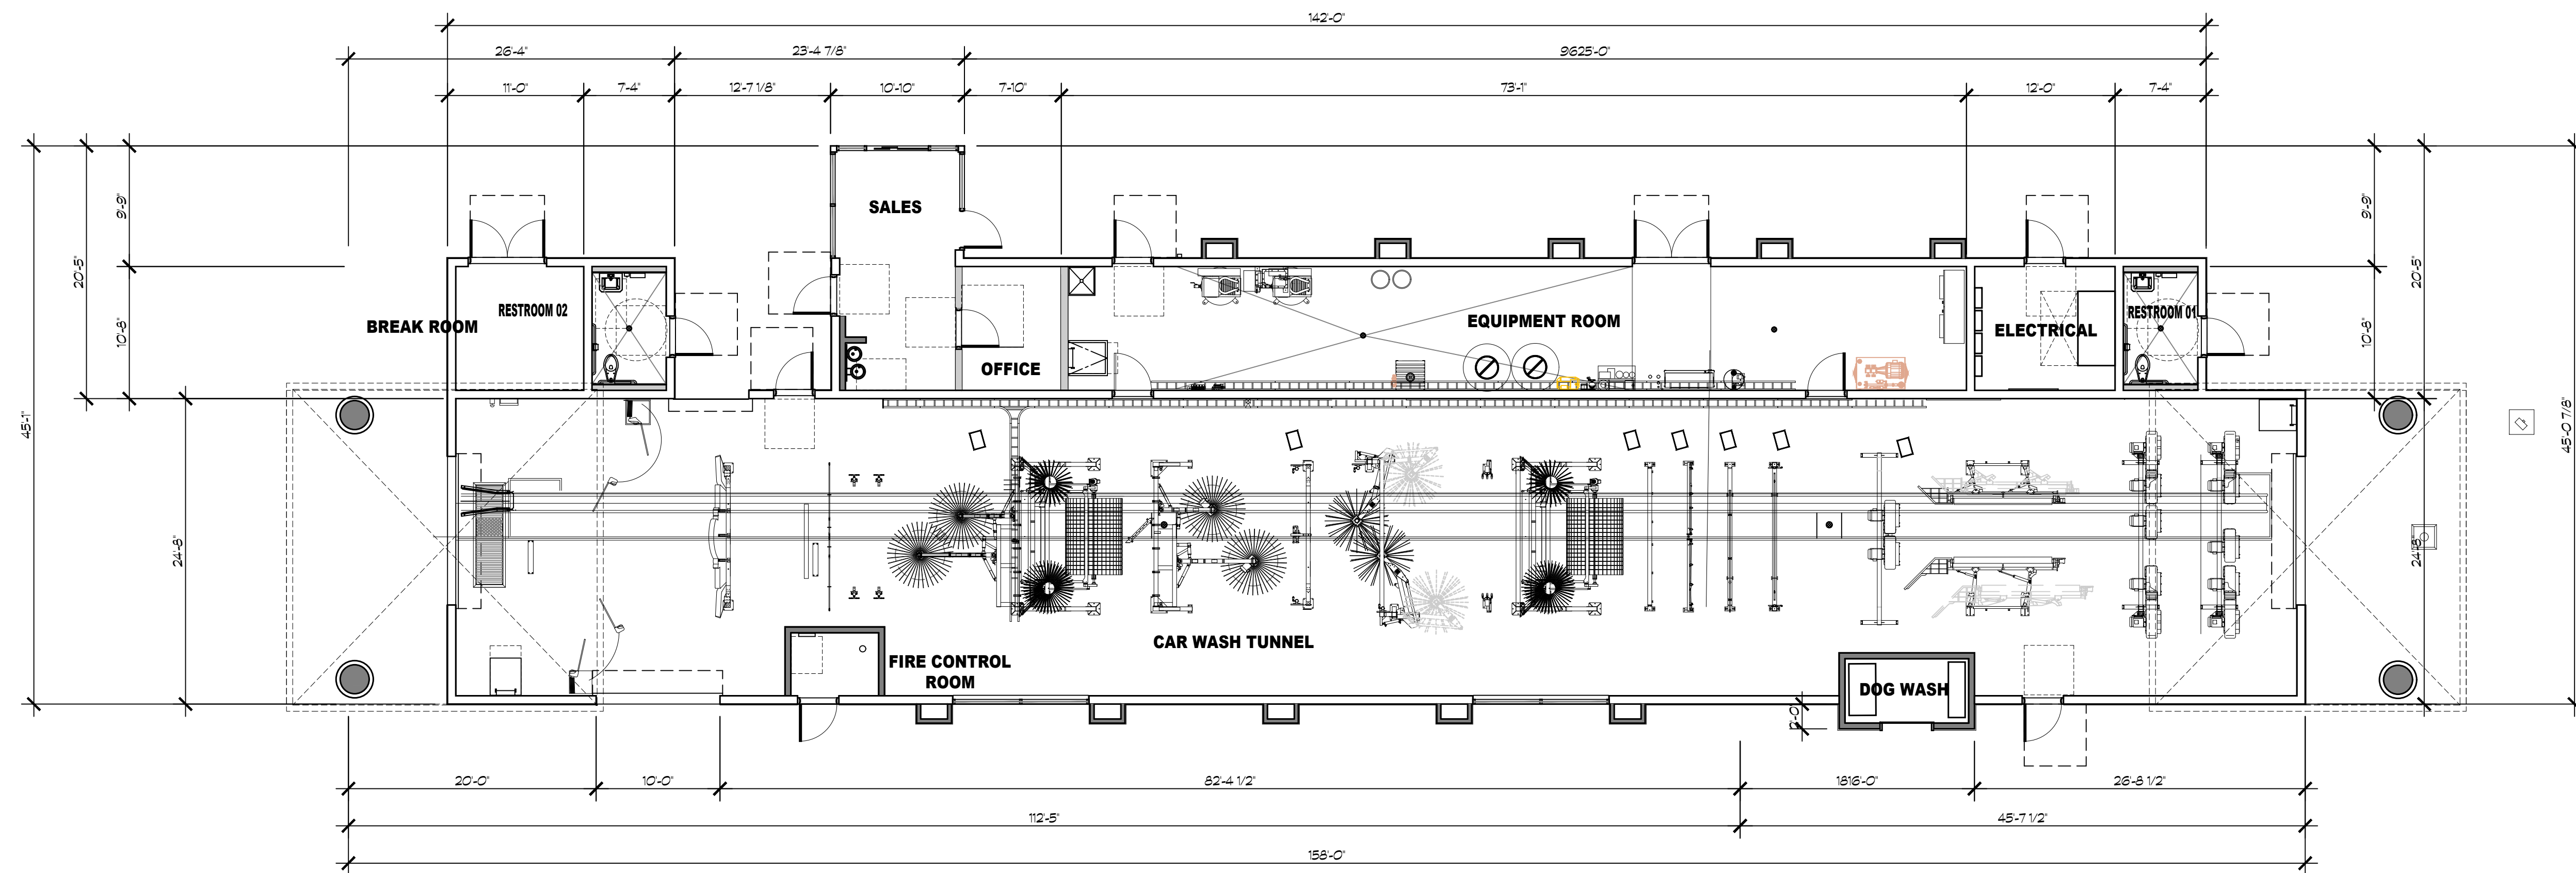

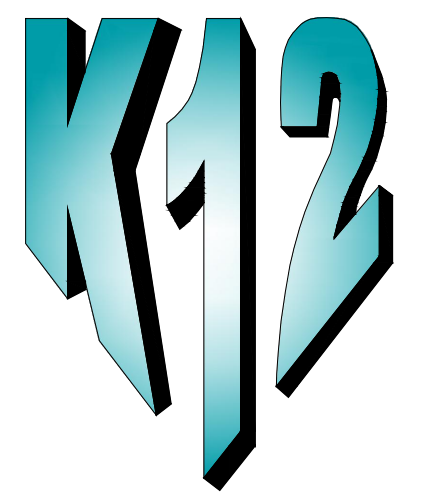

Architects

K12 Architects, Inc
3090 Fite Circle, #104
Sacramento, CA 95827

PH:(916) 455-6500 FAX:(916) 455-8100

CONSULTANTS:

CONTRACTOR:

PROJECT:

**BEE SHINE
CAR WASH**

NEW CAR WASH

**1100 ORLANDO AVE
ROSEVILLE, CA 95661**

DEVELOPER:

REVISIONS:
PLANNING COMMENTS 1/26/23

PROFESSIONAL SEALS:




PROJECT NUMBER: **22-005** PROJECT DATE: **4-12-2022**

SHEET CONTENTS:

FLOOR PLAN

SHEET NUMBER:

A201

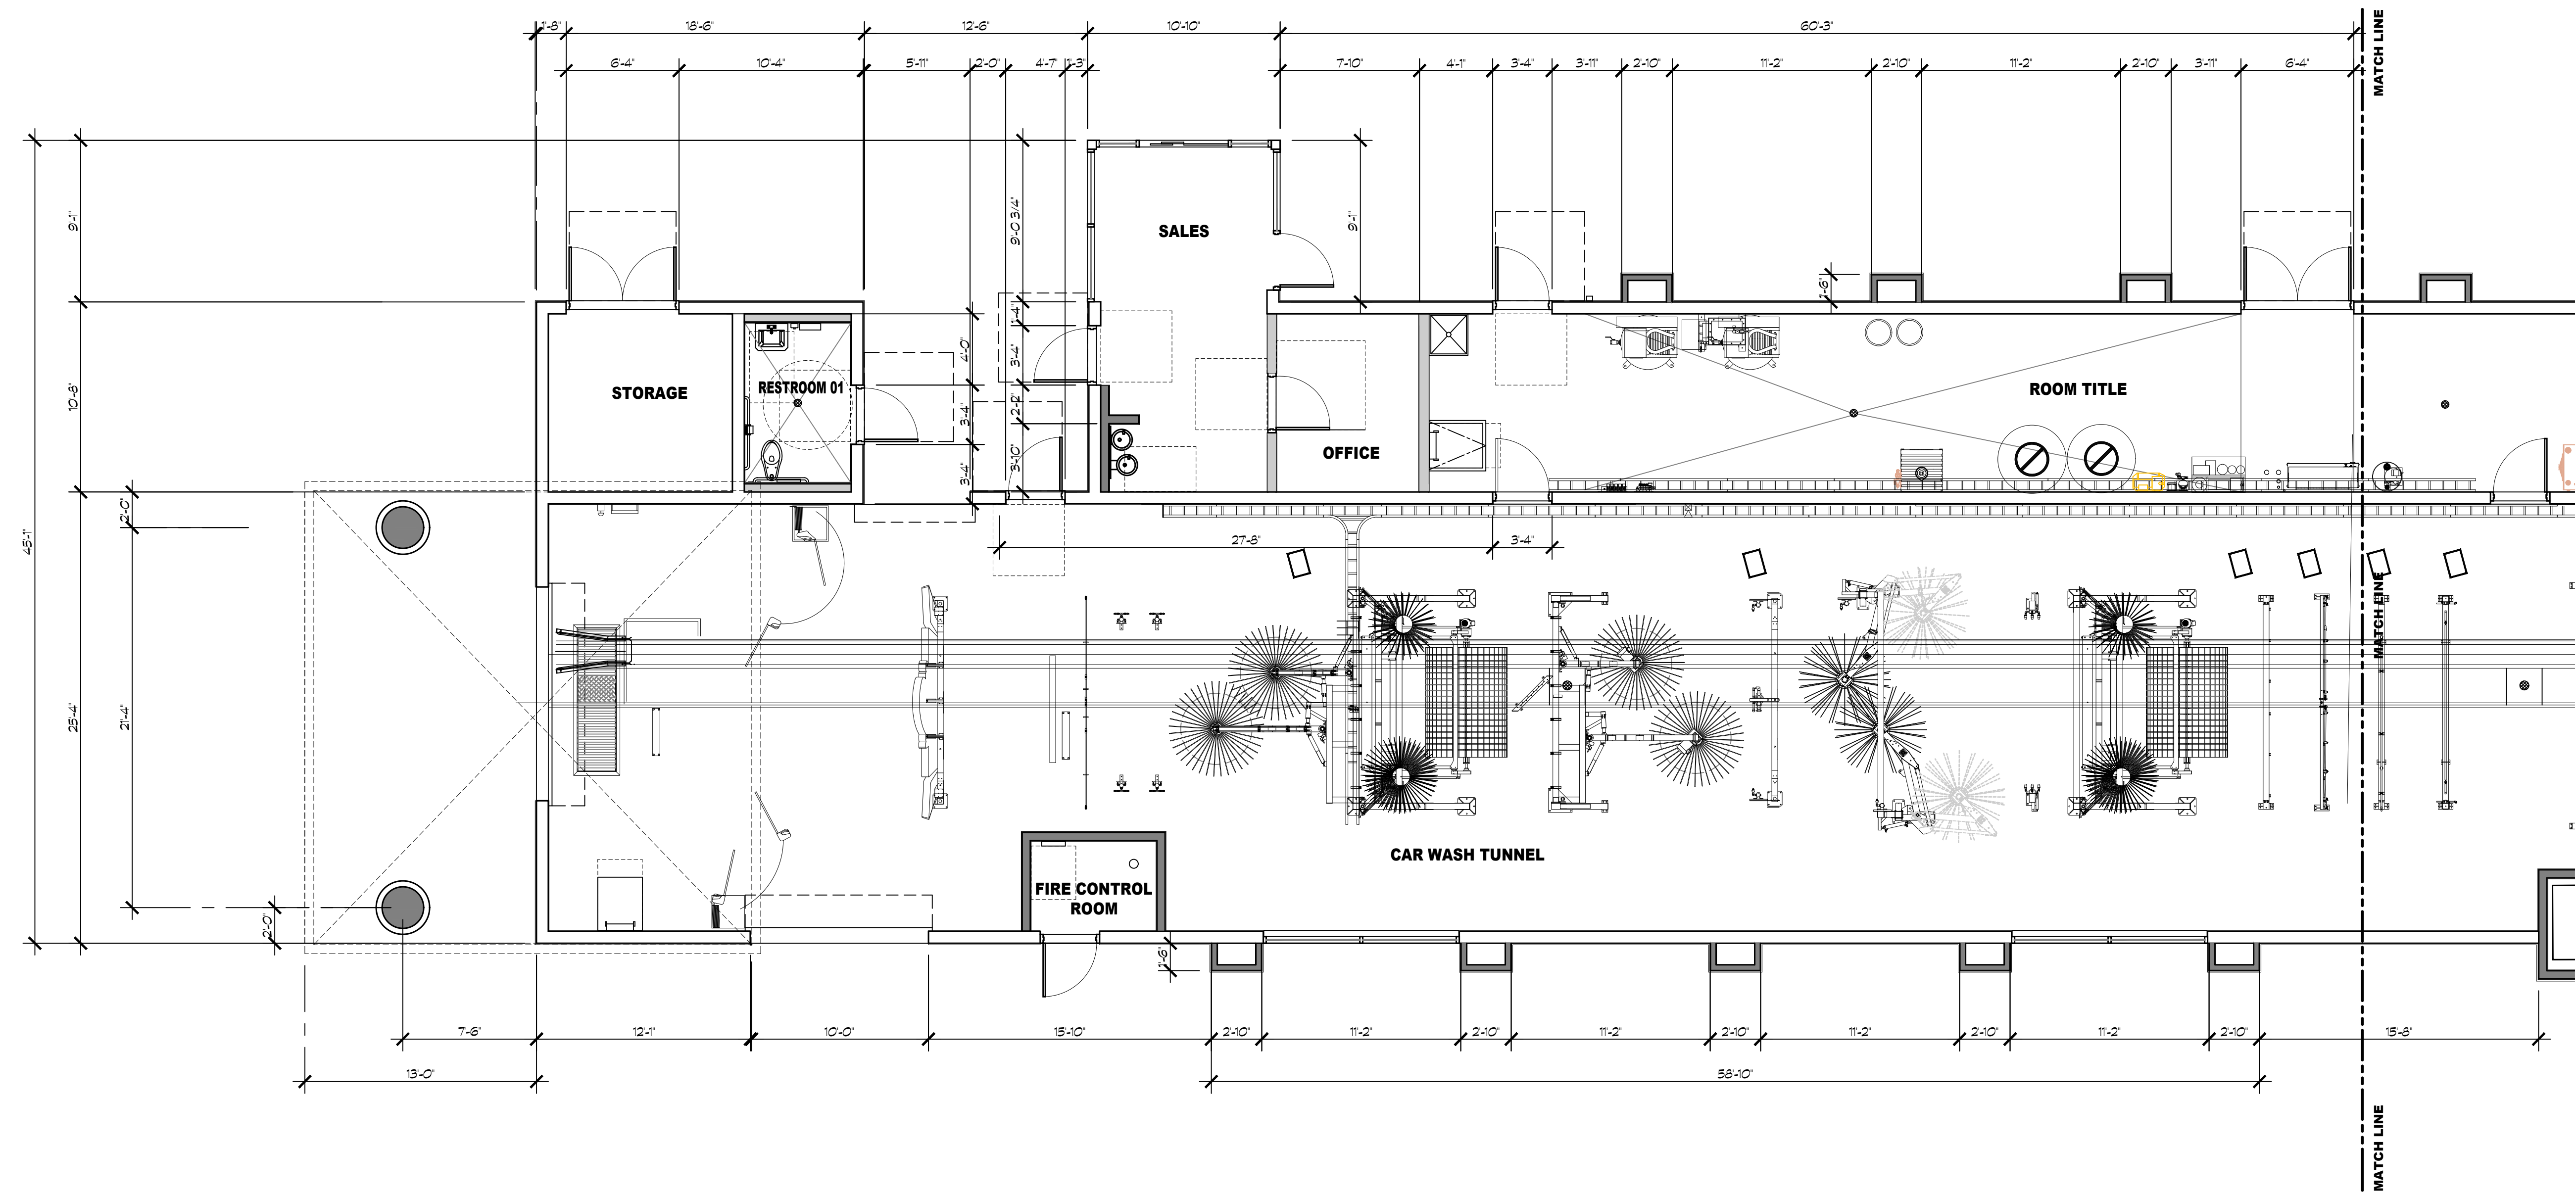



**K12
Architects**

K12 Architects, Inc
3090 Fite Circle, #104
Sacramento, CA 95827

PH:(916) 455-6500 FAX:(916) 455-8100

CONSULTANTS:

CONTRACTOR:

PROJECT:

**BEE SHINE
CAR WASH**

NEW CAR WASH


**1100 ORLANDO AVE
ROSEVILLE, CA 95661**

DEVELOPER:

REVISIONS:

PLANNING COMMENTS 1/26/23

PROFESSIONAL SEALS:

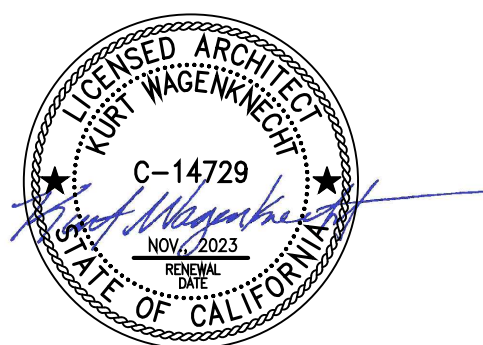

PROJECT NUMBER: **22-005** PROJECT DATE: **4-12-2022**

SHEET CONTENTS:

FLOOR PLAN

SHEET NUMBER:

A202

