



SIEGFRIED

3428 Brookside Road
Stockton, California 95219
209-943-2021
Fax: 209-942-0214
www.siegfriedeng.com


- CIVIL
- STRUCTURAL
- LANDSCAPE ARCHITECTURE
- SURVEYING
- PLANNING
- ATHLETIC FACILITY DESIGN
- GEOTECHNICAL

REVISIONS
No. Date Description

PROJECT

ALPINE CLIMB GYM - ROSEVILLE

1730 FREEDOM WAY
ROSEVILLE, CA 95678

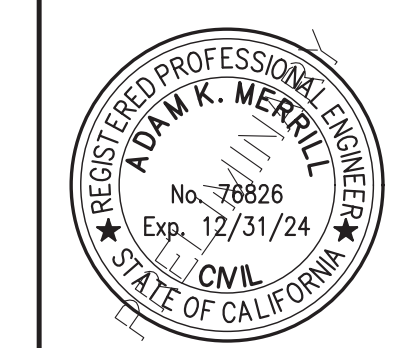

SHEET TITLE

FIRE PROTECTION PLAN


Proj Mgr	AKM
Drawn by	ARM
Date	05/11/2023
Job No.	21203

SHEET:
C6.0
9 OF: 12


LEGEND:

- SHUT OFF VALVE
- PROPOSED FIRE DEPARTMENT CONNECTION
- PROPOSED FIRE HYDRANT WITH 150' HOSE SWEEP
- FIRE LANE MINIMUM 20' WIDE

TRUCK USED:


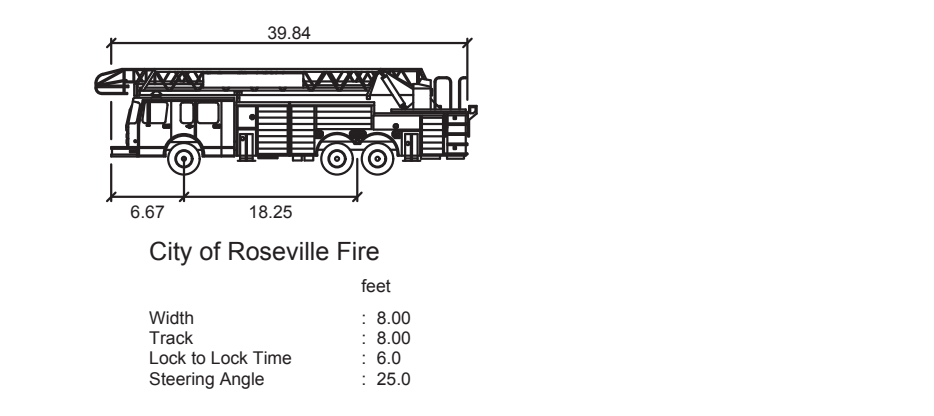


FIRE ACCESS LANE TYPICAL TURN DIMENSIONS:

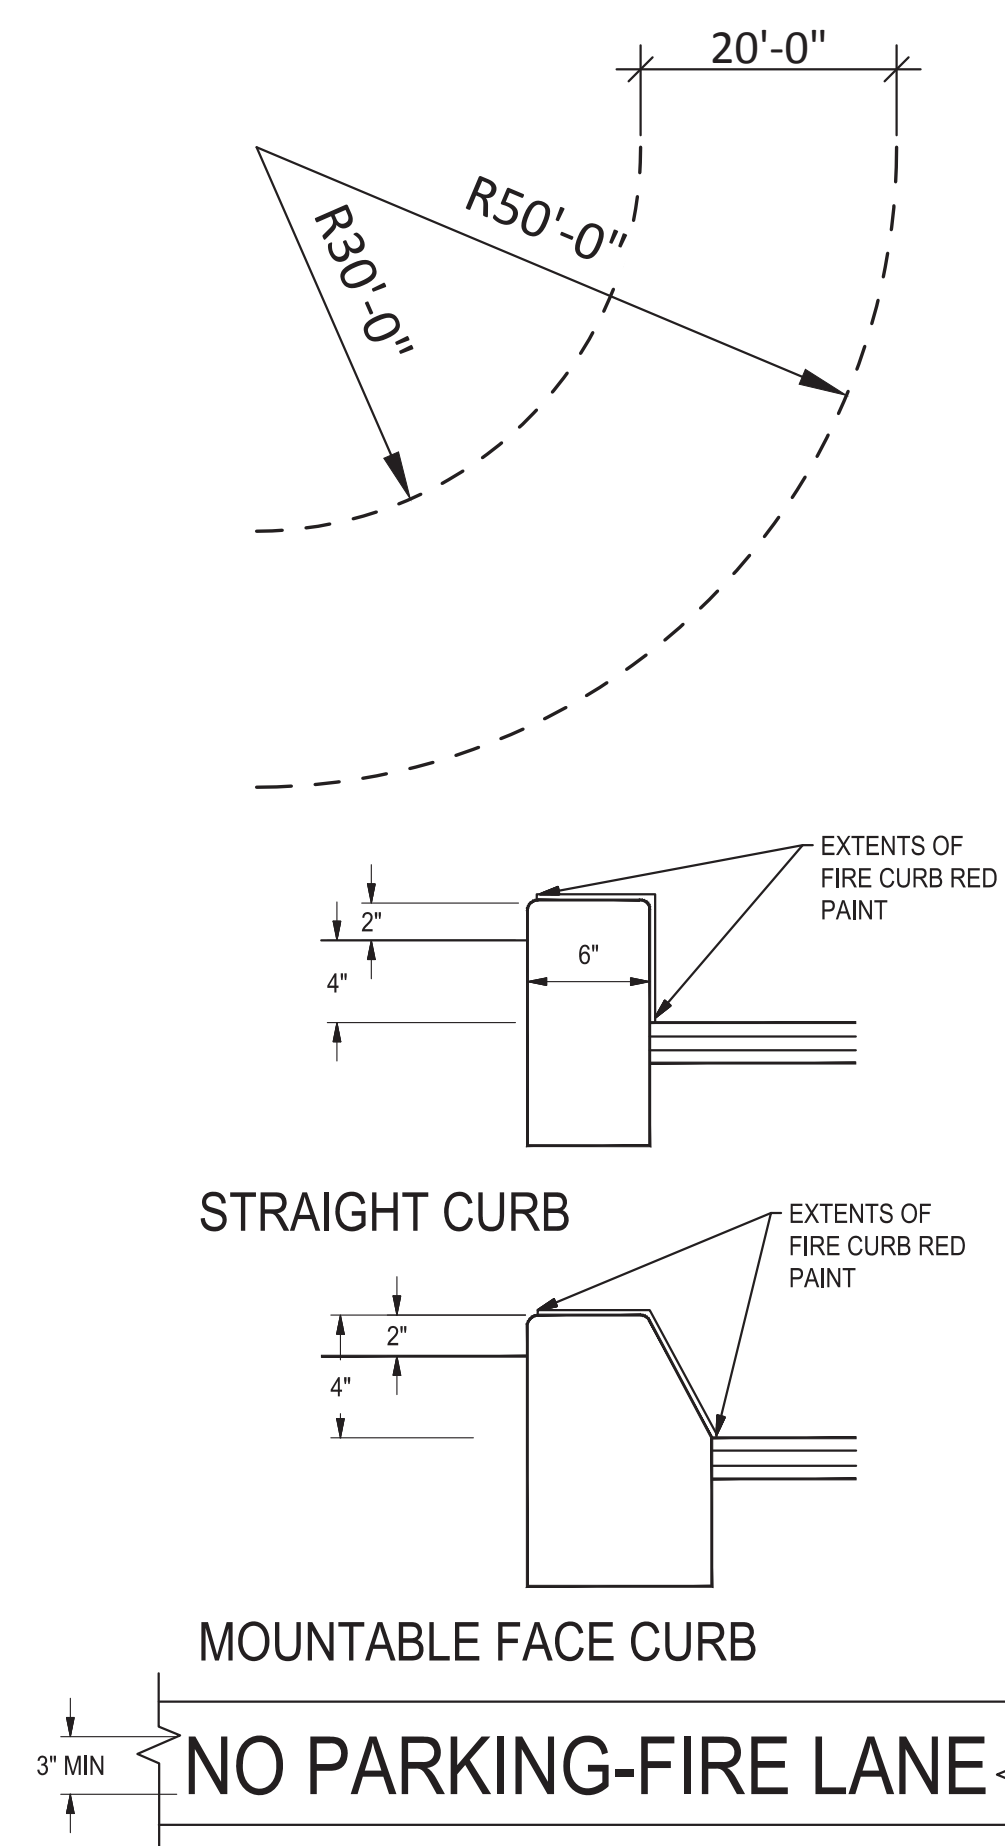

ALL RAISED CURBS IN "NO PARKING" AREAS SHALL BE PAINTED RED WITH ACCEPTABLE RED CURB/PAVEMENT PAINT AND LETTERED TO THE ABOVE STANDARD. LETTERING SHALL BE 3" HIGH (MIN), WHITE AND HAVE A 3/4" STROKE. MARKINGS TO BE LOCATED EVERY 25'-0", PER CFC 503.1. PAVEMENT MARKING DIRECT TO PAVEMENT AS INDICATED ON PLANS.

1 FIRE LANE CURB / PAVEMENT MARKING
NO SCALE

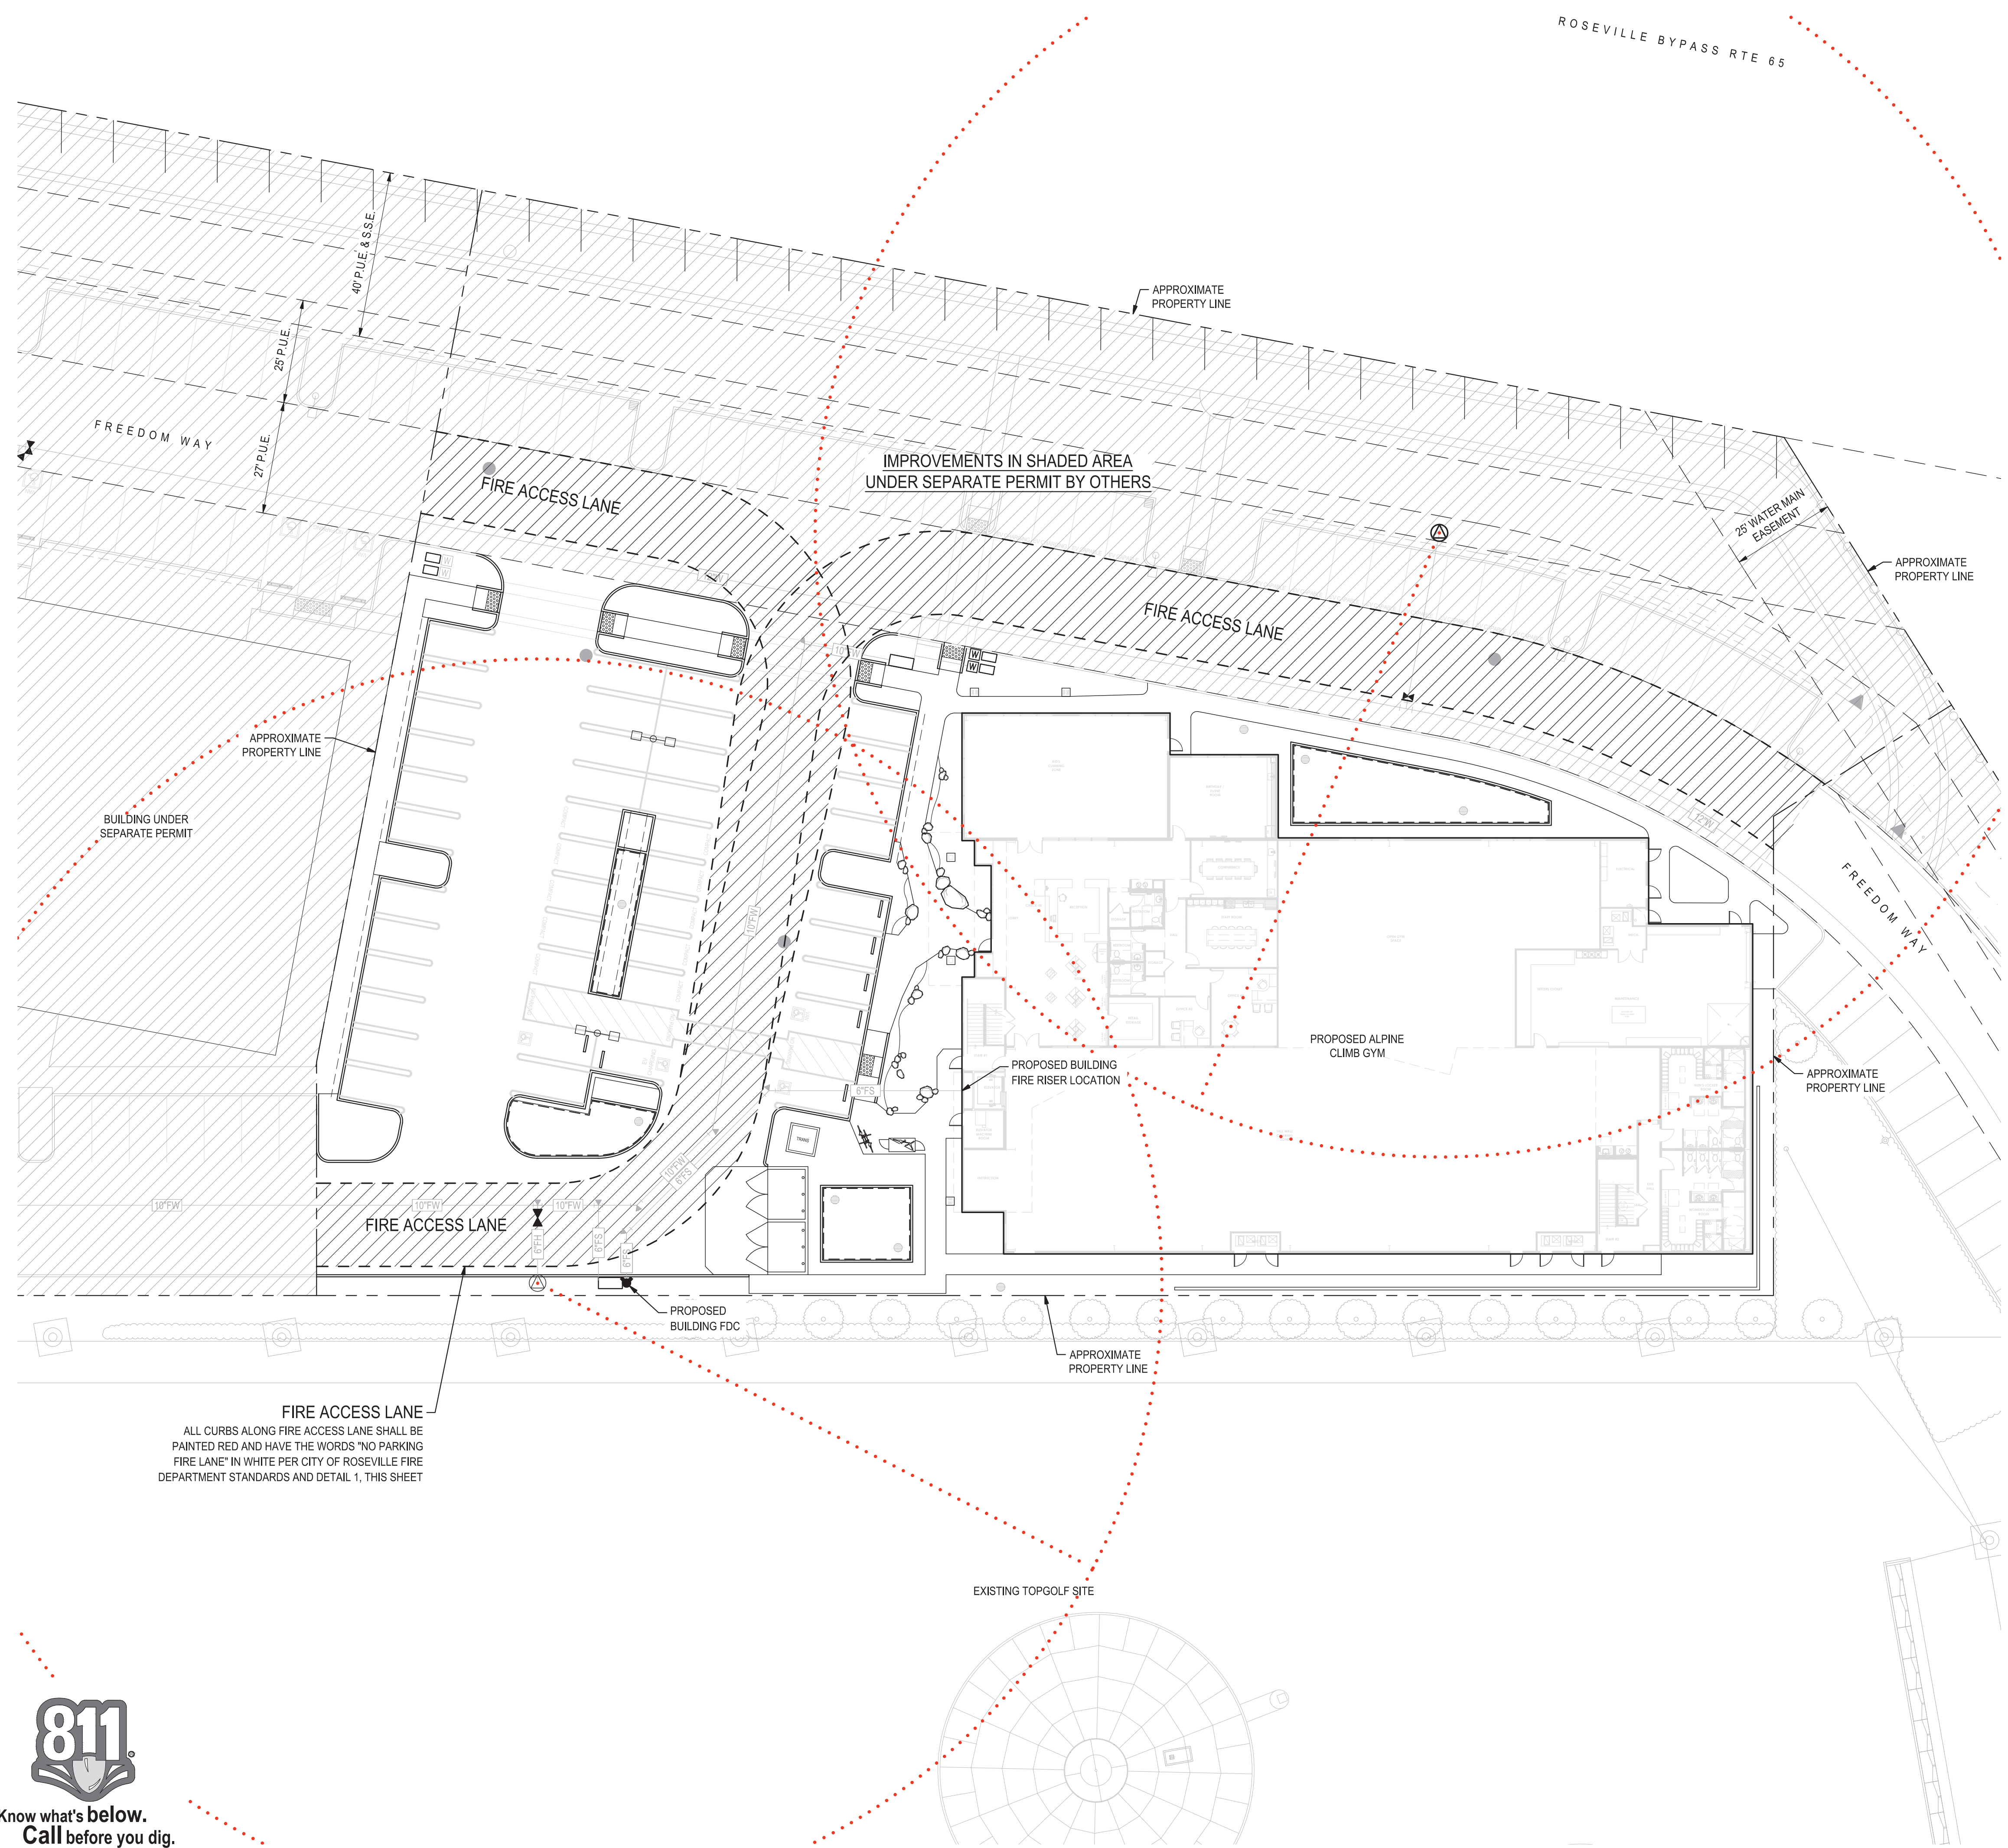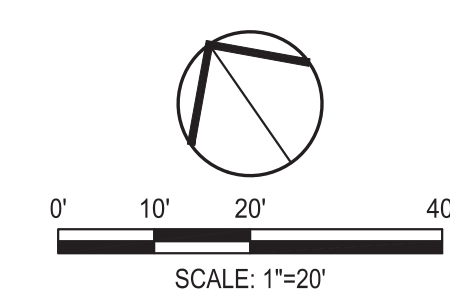

FIRE ACCESS LANE
ALL CURBS ALONG FIRE ACCESS LANE SHALL BE PAINTED RED AND HAVE THE WORDS "NO PARKING FIRE LANE" IN WHITE PER CITY OF ROSEVILLE FIRE DEPARTMENT STANDARDS AND DETAIL 1, THIS SHEET

F:\projects\21203_oplne roseville gym and graphics\entire\21203-c6.0 FIRE PROTECTION PLAN.dwg — 05/11/23

